


延床面積	497.68	m ²
2階以上床面積	313.84	m ²
消防団専用面積	183.84	m ²


凡例	筋カイ	90×45	90°
	筋カイ	90×45	225°

平面図 S=1:100

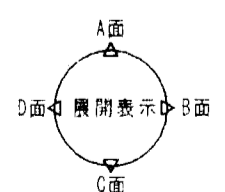



北面

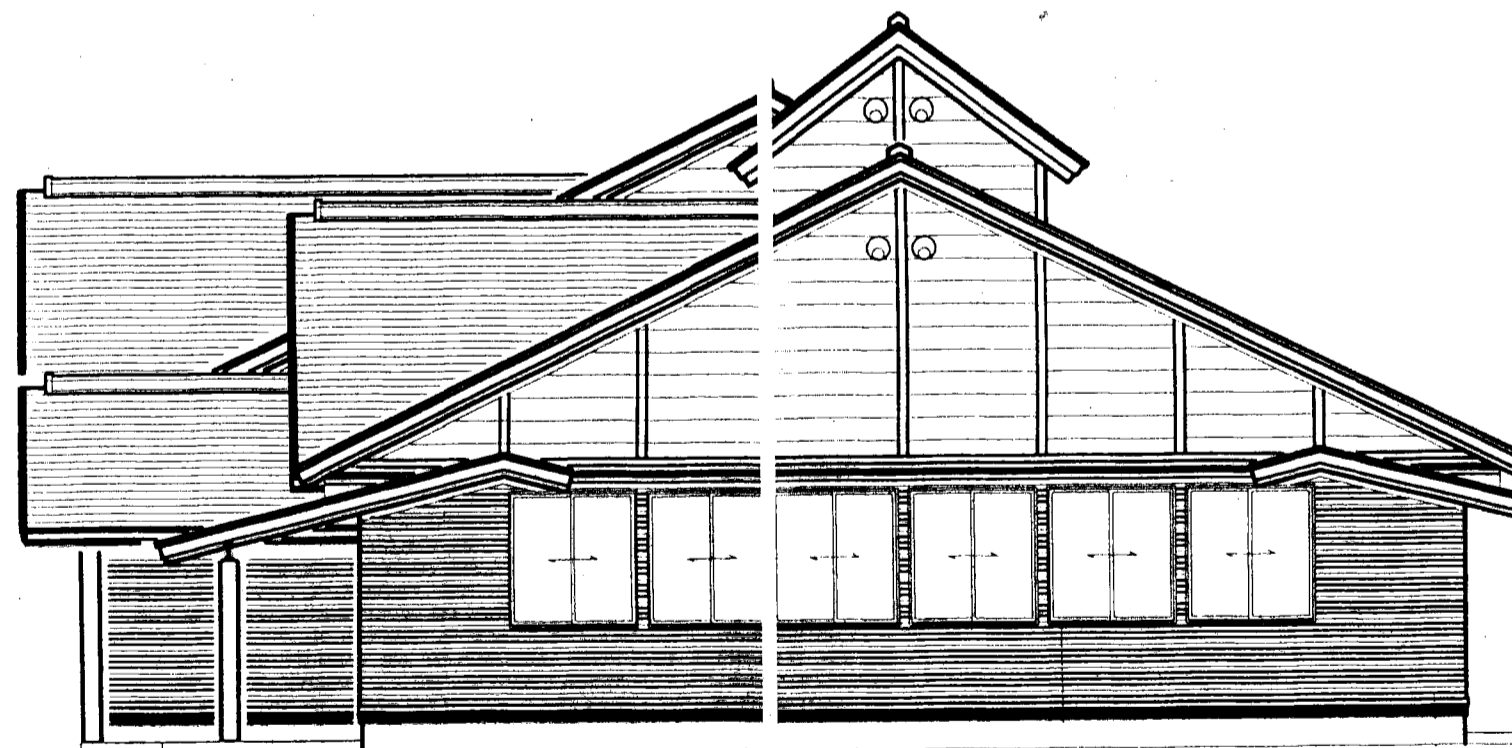

西面

立面 N01 S=1:100




02.12

D 8


建築

立面図 N01

S=1:100

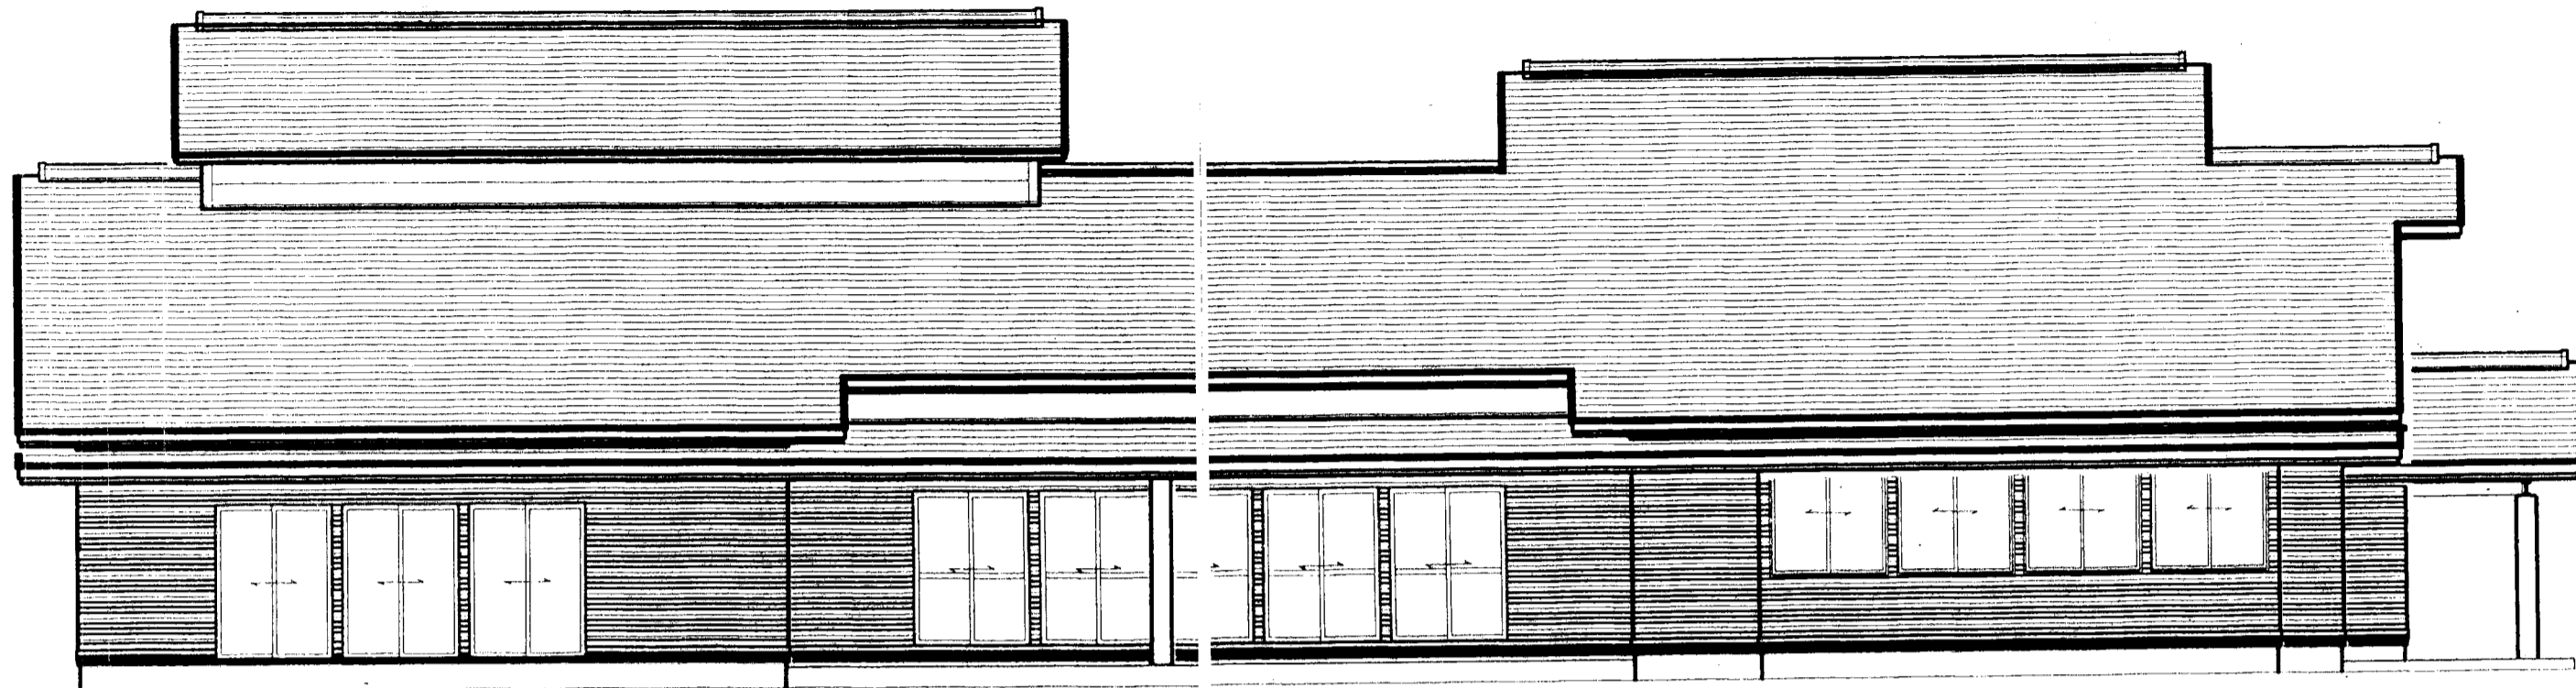



南面

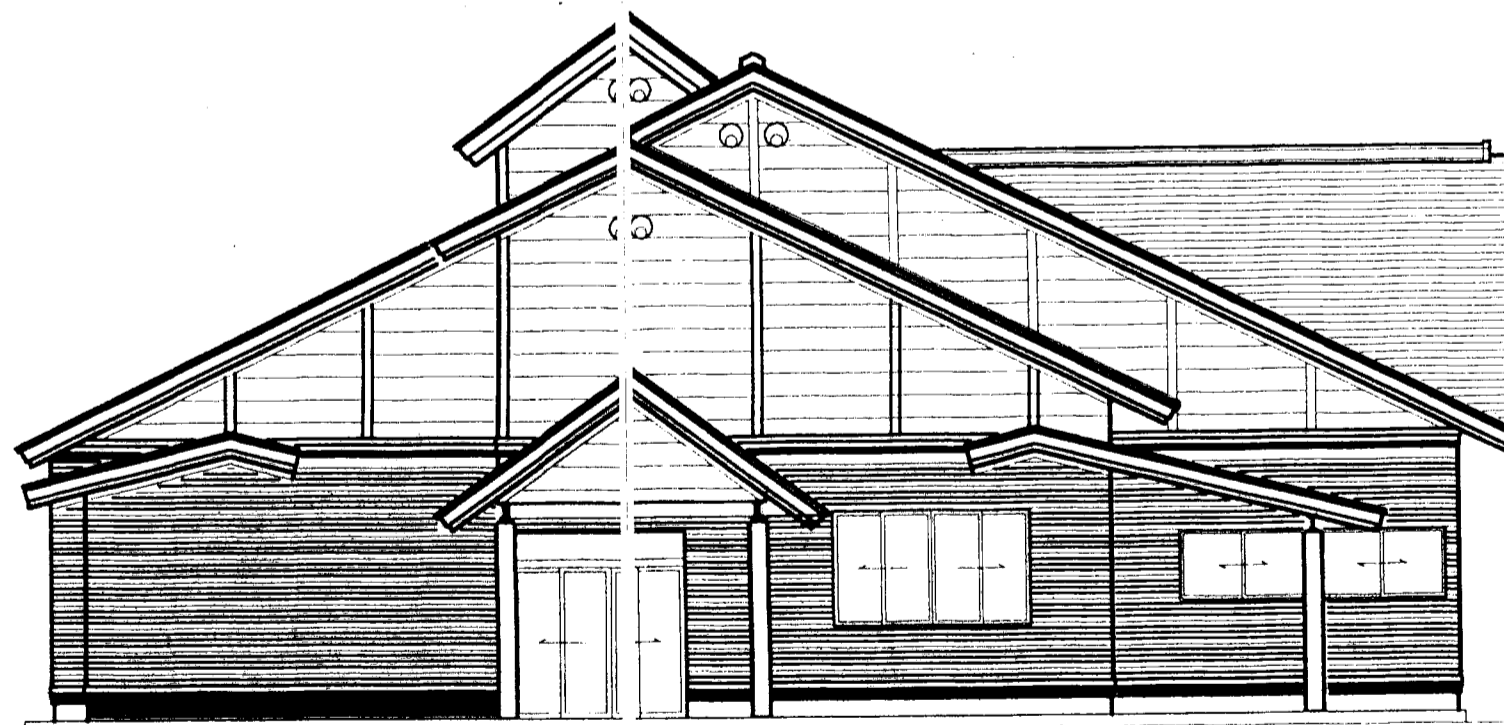

東面

立面 N02 S=1:100





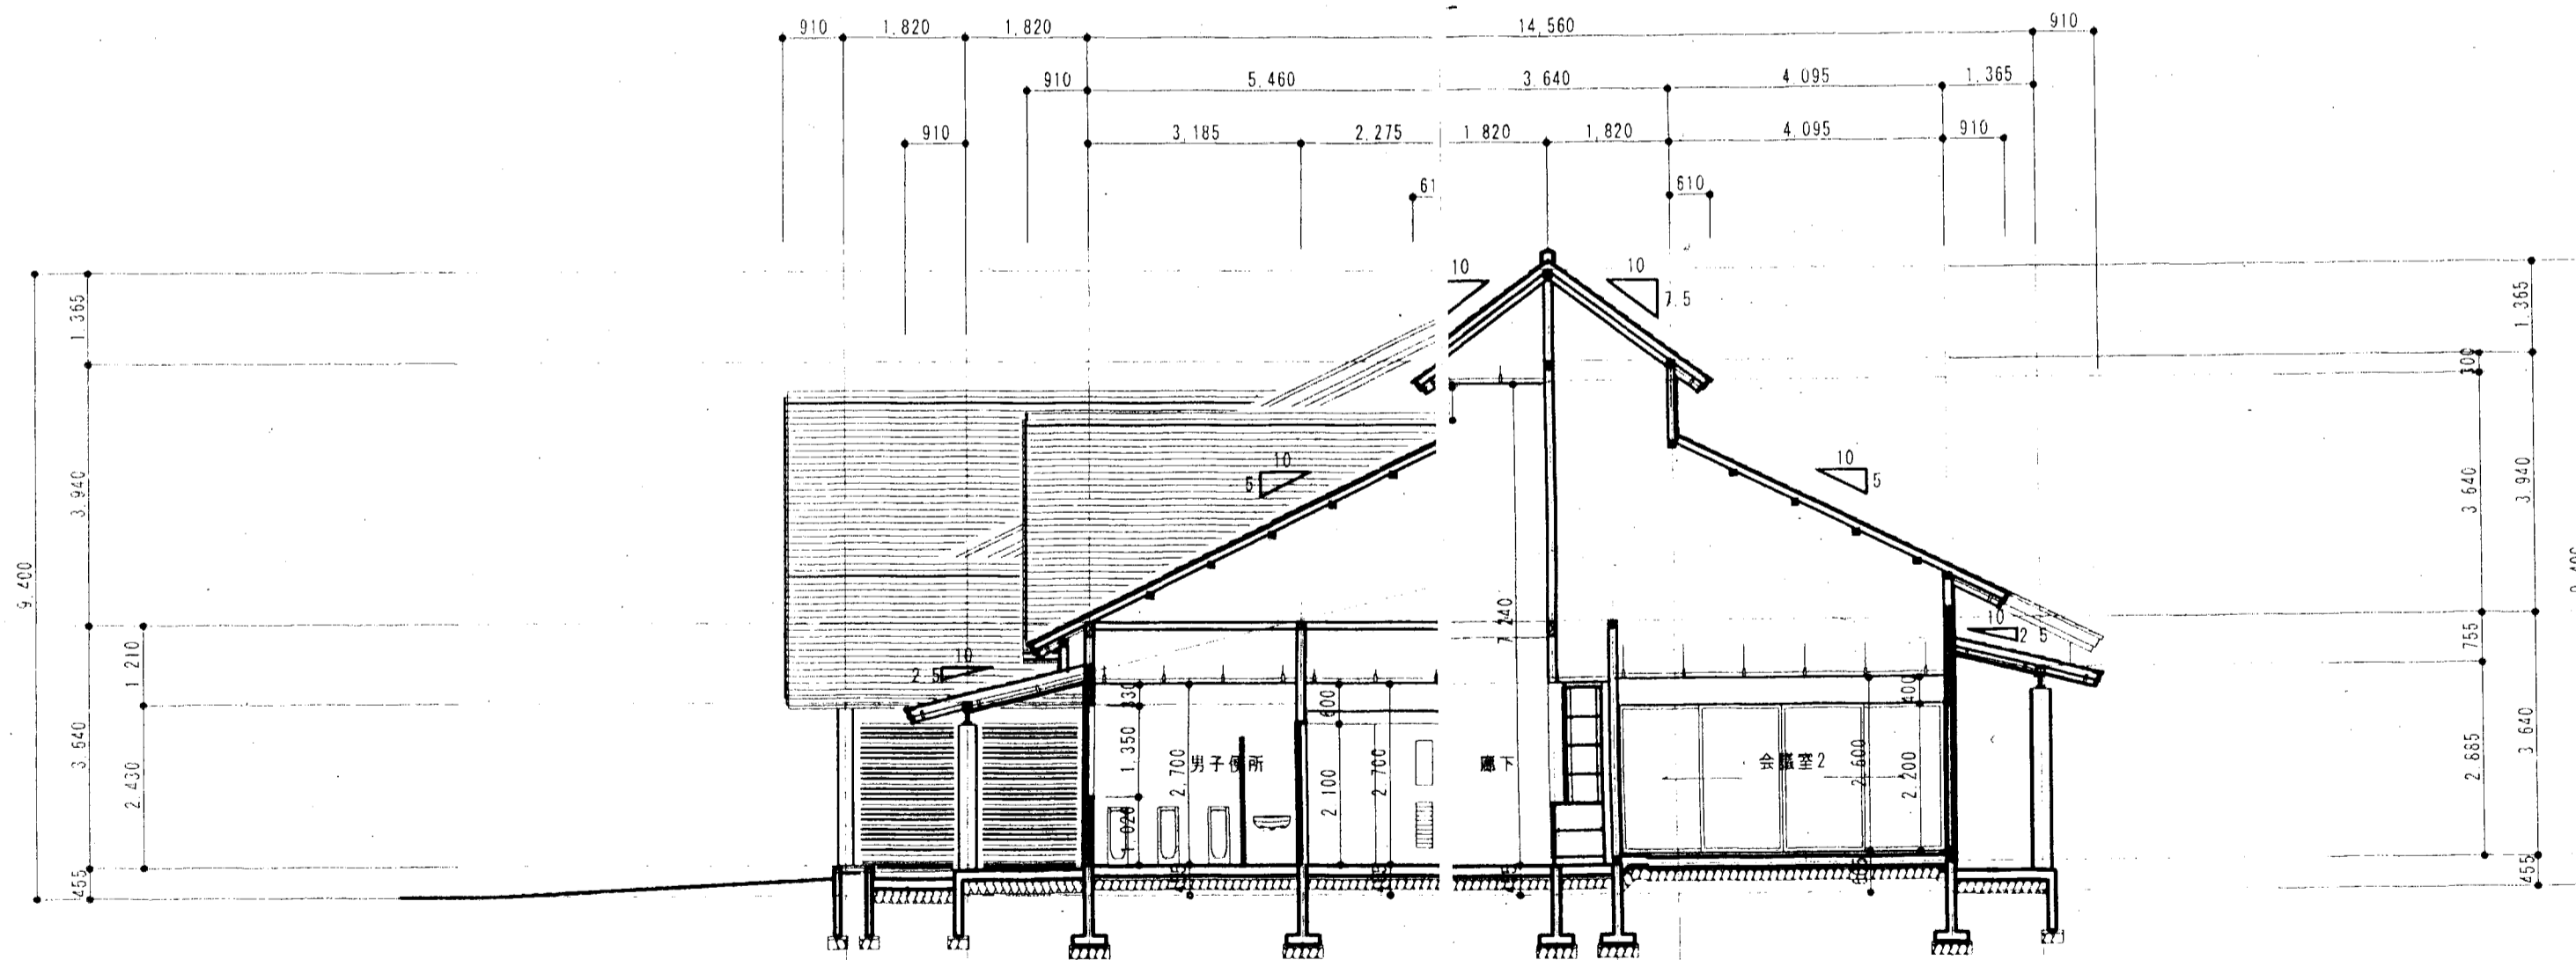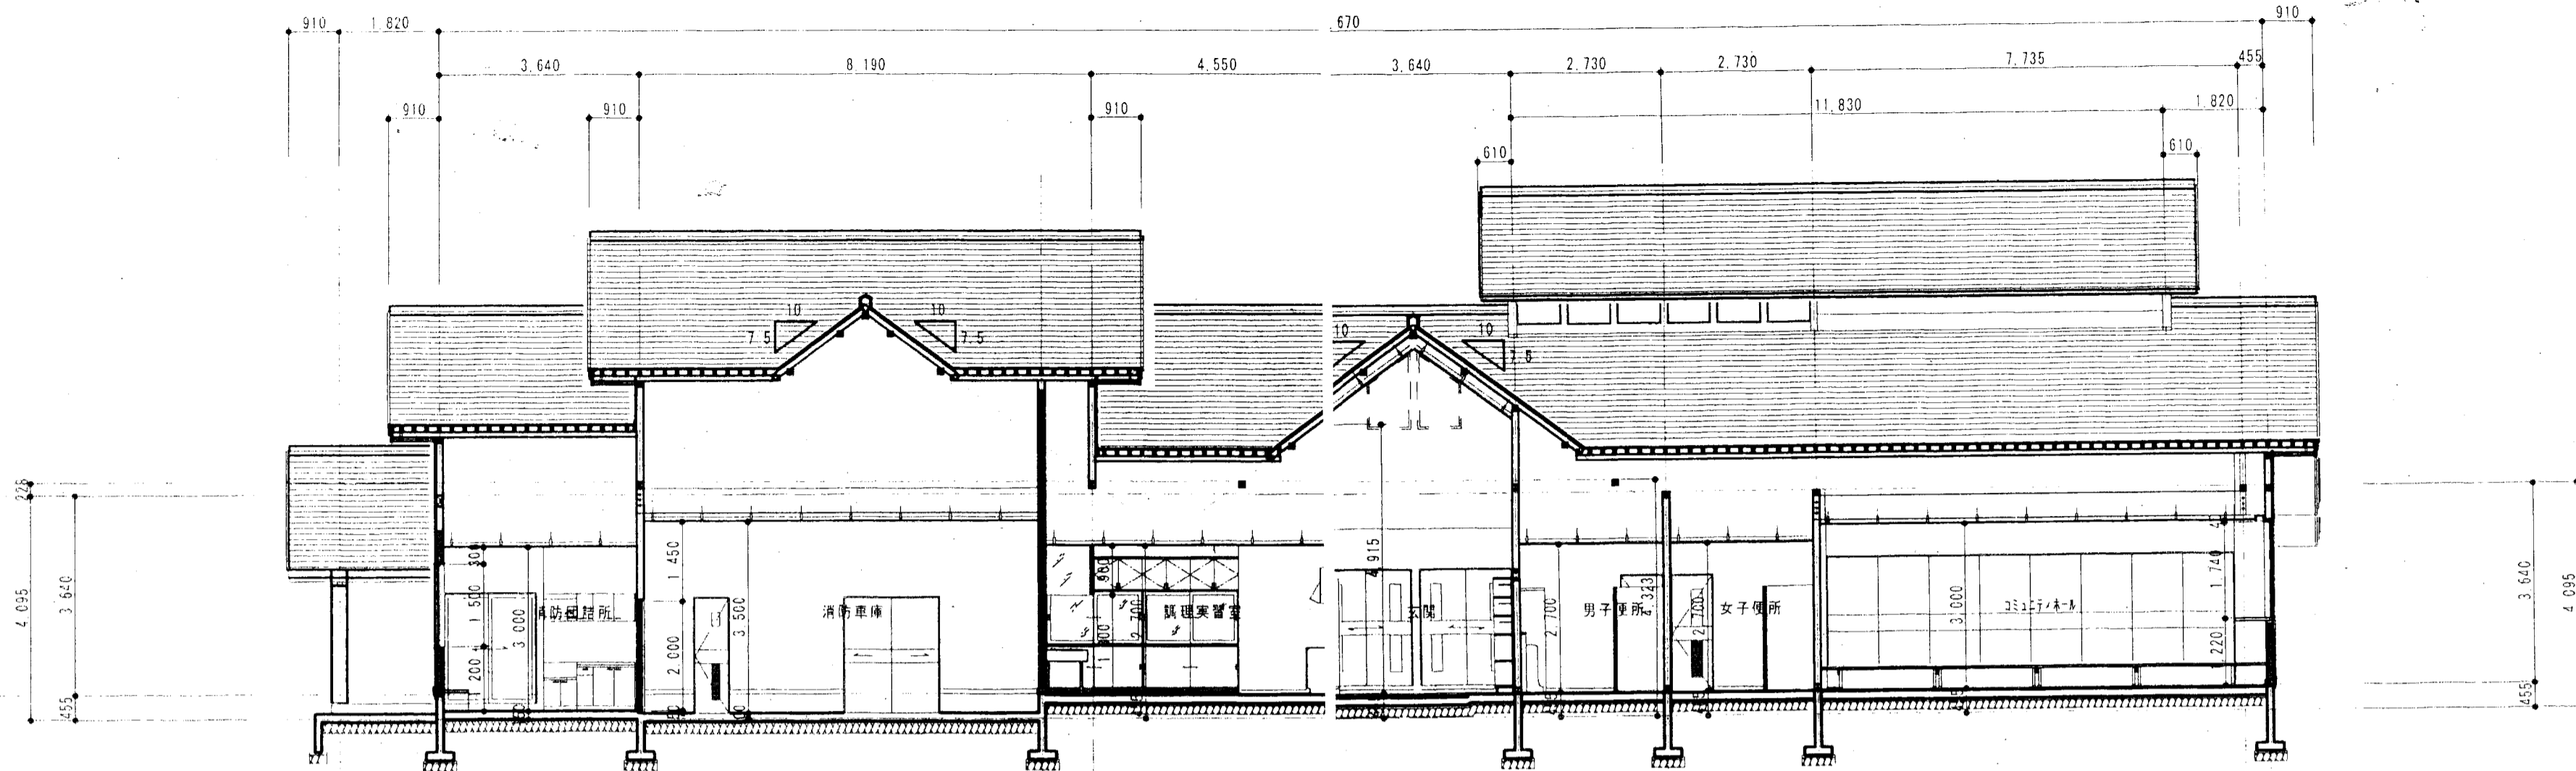

断面 N01 S=1/100



検図	製図	日付	図番	区分	図名	縮尺
稲葉	阿部	07.12	D-10	建築	断面図 N01	S=1/100

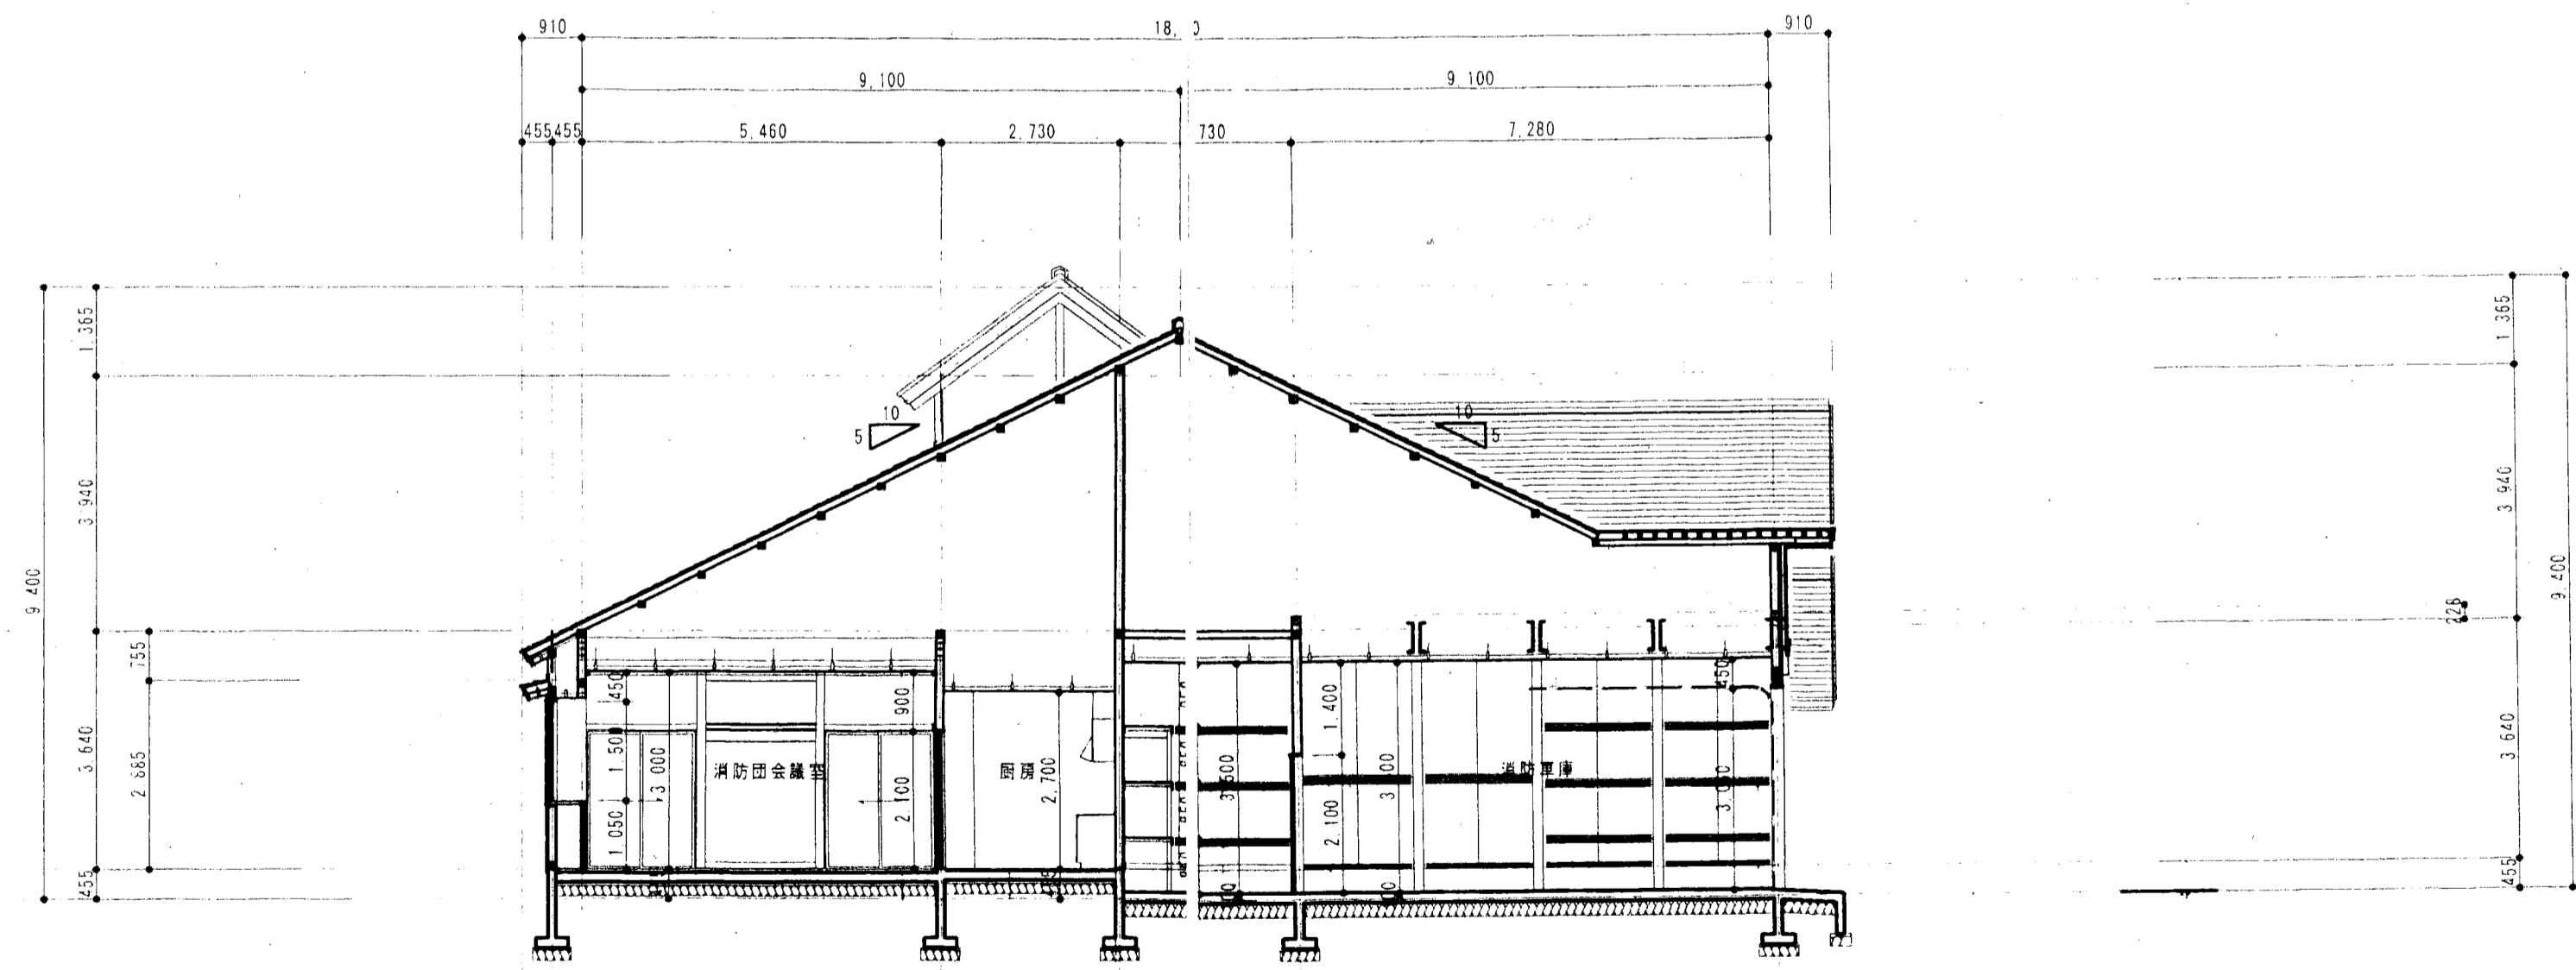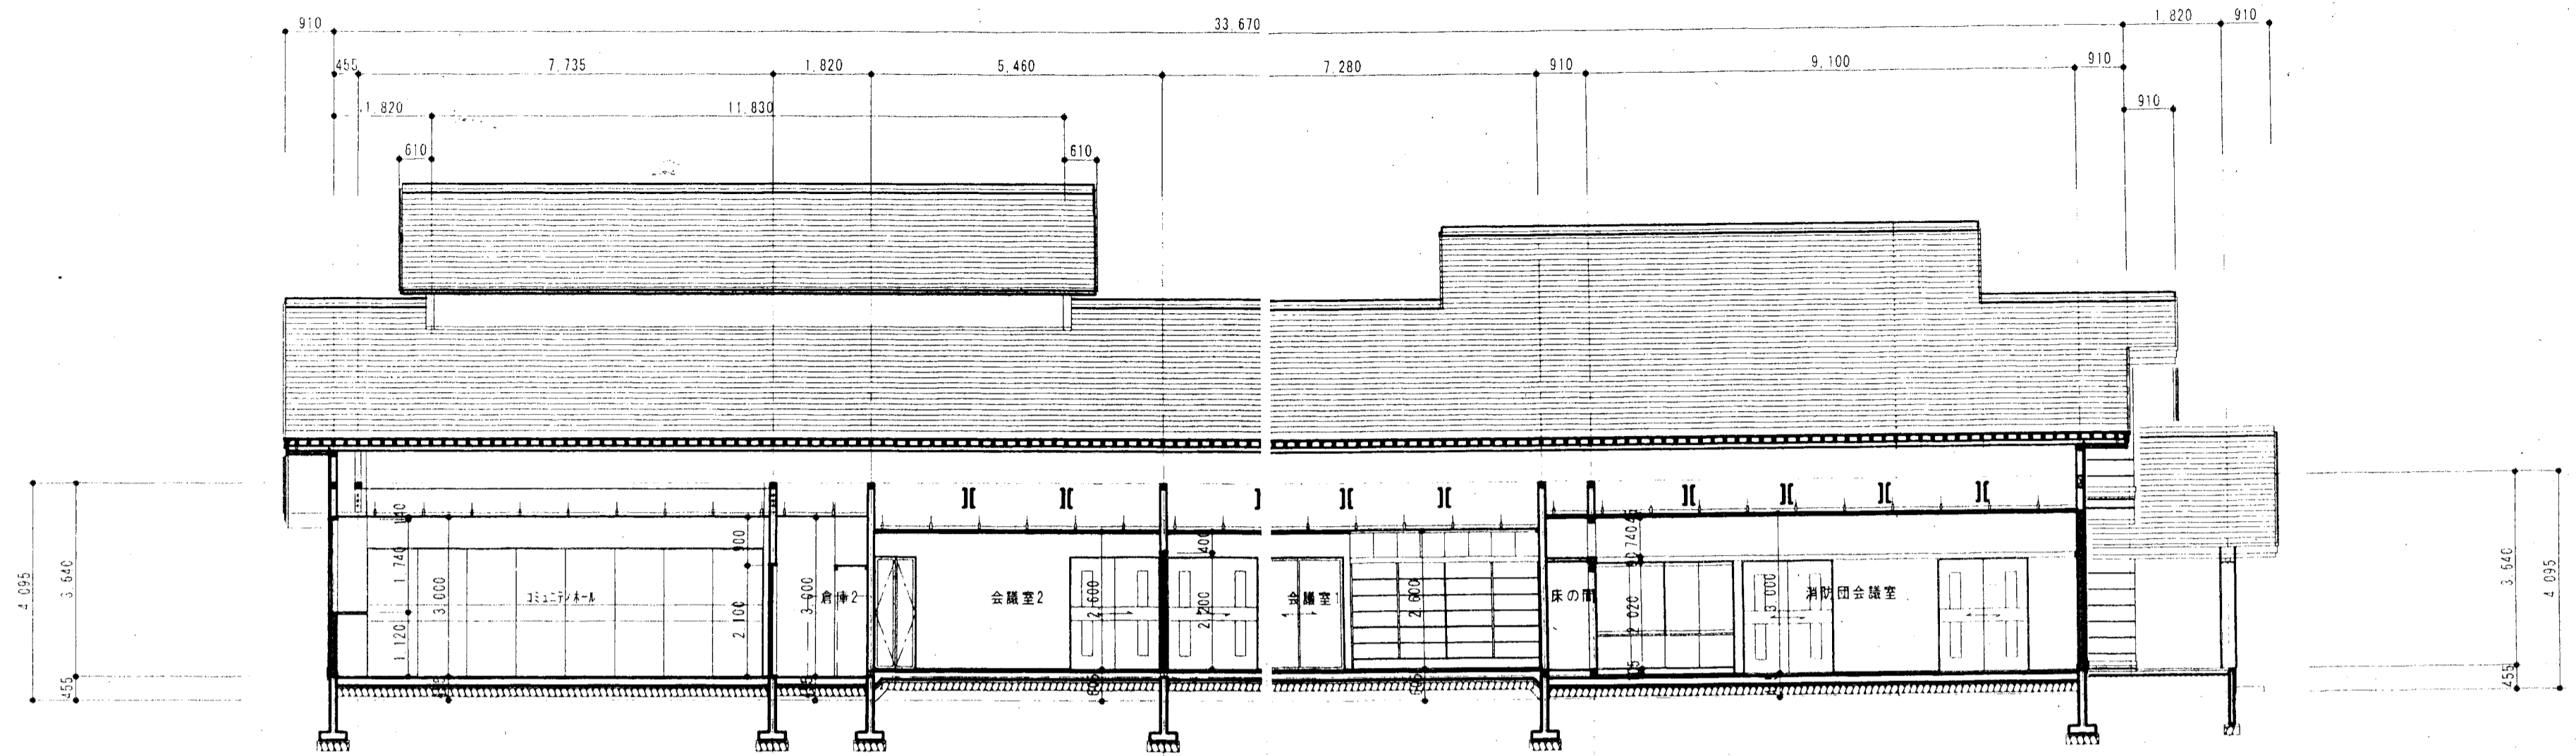

断面図 N02 S=1:100

